

RFP 170457/ME - ADDENDUM 3

RFP Deadline: **March 5, 2020 at 2:00 PM** (Local Time)

Page: **1 of 4**

RFP Number: **170457/ME**

Date: **March 2, 2020**

RETURN PROPOSALS AS SHOWN BELOW

Copies of proposal required:

Seven (7) Copies

FAX or TELEX Bids Permitted: ☐ YES ☒ NO

Physical Address for Courier Delivery:

The University of Texas MD Anderson Cancer Center
Attn: Mary Mueller
Fannin Holcombe Building
6900 Fannin, 10th Floor, Suite FHB10.1000
Houston, Texas 77030

PROPOSALS MUST BE SUBMITTED IN A **SEALED** ENVELOPE/BOX IDENTIFIED BY THE COMPANY NAME. **RFP NUMBER MUST BE SHOWN ON THE LOWER LEFT HAND CORNER OF THE ENVELOPE/BOX.**

PROPOSALS MAY BE SUBMITTED AT ANY TIME UNTIL RFP DEADLINE NOTED ABOVE.

THE UNIVERSITY OF TEXAS MD ANDERSON CANCER CENTER RESERVES THE RIGHT TO REJECT ANY AND ALL PROPOSALS OR ANY PART THEREOF.

RESPONDENT MUST COMPLETE AND SIGN BELOW

Company Name: _____

Mailing Address: _____
(STREET OR BOX #)

(CITY) (STATE) (ZIP)

Telephone No.: _____ / _____

E-Mail: _____

(Authorized Signature)

(DATE)

(Typed or Printed Name and Title)

THIS RFP ADDENDUM IS A FURTHERANCE OF A SOLICITATION FOR PROPOSALS
AND IS NOT A CONTRACT OR OFFER TO CONTRACT.

El Rio E Infrastructure Updates

- Addendum 3 is attached. This Addendum revises the purchase and installation of all security devices from:
from: Owner Furnished / Owner Installed
to: Contractor Furnished / Contractor Installed.**

Mary Mueller (Sourcing Specialist)

E-Mail address: memuelle@mdanderson.org

ADDENDUM NUMBER THREE

24 FEBRUARY 2020

MD Anderson Cancer Center
El Rio Infrastructure Updates
MDACC Project No. 17-0457
CH+P Project No. 18-024

Architects
COURTNEY HARPER + PARTNERS, L.C.
3801 Kirby Suite 244
Houston, TX 77098

MEP Engineer
PBS / BENCOV ENGINEERS, INC.
5700 NW Central Dr., Suite 402
Houston, TX 77092

Civil and Structural Engineer
WALTER P. MOORE, INC.
1301 McKinnery, Suite 1100
Houston, Texas 77010



NOTICE TO ALL BIDDERS:

This Addendum forms a part of the Contract Documents and modifies the original Project Manual and Drawings, Issued for CSP and TDLR Review dated 29 October 2019 to the extent noted hereinafter. Receipt of the Addendum must be acknowledged on the Bid/Proposal Form.

Careful note of this Addendum shall be taken by all parties of interest so that proper allowance is made in all computations, estimates and contracts and so that all trades affected are fully advised in the performance of work that will be required by them.

This Addendum supersedes all previous Drawings, Specifications and instructions pertaining to these items.

Drawings

3.01 Sheet A.0.01 Index, Symbols & Abbreviations, etc . Remove and replace this sheet with the attached A.0.01. Revisions are clouded and noted as "Addendum No. 3."

3.02 Sheet A.2.13 Security Plan. Remove and replace this sheet with the attached A.2.13 Security Plan. Revisions are clouded and noted as "Addendum No. 3."

END OF ADDENDUM NO. 03

REFER TO FINISH SCHEDULE FOR ADDITIONAL ABBREVIATIONS

DO NOT SCALE DRAWINGS. USE FIGURED DIMENSIONS ONLY.

FIELD VERIFY ALL DIMENSIONS BEFORE PROCEEDING WITH THE WORK. ENLARGED PLANS, WHERE ENLARGED PLANS OR PARTIAL PLANS ARE REFERENCED, DIMENSIONS AND SPECIAL DETAILING OR FINISH REQUIREMENTS ARE NOTED ON THE ENLARGED PLANS AND NOT OMITTED ON THE OTHER PLANS.

EXIST. CONDITIONS: ONLY THE AREAS DESCRIBED IN THE PROJECT SCOPE HAVE BEEN FIELD VERIFIED. "FIELD VERIFIED" MEANS THAT EXIST. PARTITIONS HAVE BEEN PARTIALLY LOCATED. MOST OF THE PARTITIONS HAVE BEEN LOCATED. AREAS THAT ARE CONCEALED OR OTHERWISE NOT ACCESSIBLE HAVE NOT BEEN VERIFIED. THE PARTITIONS SHOWN IN THE RENOVATED AREAS ARE DERIVED FROM THE OWNER PROVIDED DOCUMENTS.

IF NECESSARY, FOR CONTINUITY OF FACE PLANES OF PARTITIONS, PROVIDE ADDITIONAL LAYER(S) OF GYPSUM BOARD. THICKER STUDS TURNING OR OTHER APPROVED MEANS TO ACCOMPLISH THESE REQUIREMENTS WITHOUT REDUCING THE PHYSICAL EFFECTS OF THE SCHEDULED PARTITION TYPE.

INSTALL ALL BACKING PLATES FOR ALL MOUNTED RAILINGS, TOILET AND SERVICE ACCESSORIES, WALL MOUNTED CASEWORK, MILLWORK OR FURNITURE, AND WALL MOUNTED DOOR BUMPERS.

DO NOT PROVIDE BACKING PLATES BEHIND GYPSUM BOARD AT ALL LOCATIONS WHERE HORIZONTAL WOOD GROUNDS ARE TO BE APPLIED.

UNO, ALL PLAN DIMENSIONS SHOWN ARE TO FINISHED FACE OF GYPSUM BOARD OR FINISH WALL SURFACE.

REPAIR EXIST. SURFACES TO MATCH EXIST. ADJACENT SURFACES WHERE EXIST. ITEMS ARE REMOVED OR NEW ITEMS ARE INSTALLED.

CONTRACTOR SHALL COORDINATE ALL WORK TO BE PERFORMED BY OTHERS.

THE WORK SHALL COMPLY WITH OR BE IN EXCESS OF ALL M.D. ANDERSON CANCER CENTER (MDACC) BUILDING STANDARDS.

THE WORK SHALL COMPLY WITH ALL APPLICABLE BUILDING CODES, LAWS AND ORDINANCES INCLUDING THE TEXAS ACCESSIBILITY STANDARDS (TAS) OF THE TEXAS DEPARTMENT OF LICENSING AND REGULATION (TDLR).

ALL SUBSTITUTIONS AND CHANGES TO THESE DRAWINGS MUST BE SUBMITTED TO THE ARCHITECT FOR APPROVAL.

WHERE THE TERM "APPROVED" OR "EQUAL" IS USED, IT SHALL BE INTERPRETED TO MEAN THAT THE PREFERENCE IS MADE TO THE RULING AND JUDGEMENT OF THE MDACC PROJ. MANAGER AND THE PROPOSED SUBSTITUTION SHALL BE SUBMITTED FOR REVIEW AND WRITTEN APPROVAL.

SCHEDULE ALL ELECTRICAL POWER, PLUMBING, SECURITY, MECHANICAL, AND COMMUNICATION FIRE ALARM OUTAGES WITH OWNER'S REPRESENTATIVE ADVISING REQUIRED ADVANCE NOTICE PRIOR TO OUTAGE.

PROTECT ALL WORK SCHEDULED TO REMAIN FOR DURATION OF CONSTRUCTION.

FLOOR SURFACE TO BE PATCHED AND PREPARED FOR SCHEDULED FINISHES PRIOR TO INSTALLATION OF ALL FLOOR FINISHES. VOIDS TO BE FILLED WITH LEVELING COMPOUND CONSOLIDATED FOR EXTERIOR USE.

R. TAG REQUIRED SIGNAGE TO BE OWNER PROVIDED AND OWNER INSTALLED.

5. DRAWINGS AND SPECIFICATIONS SHALL REMAIN THE PROPERTY OF THE ARCHITECT AND MAY NOT BE REPRODUCED IN ANY MANNER WITHOUT EXPRESSED WRITTEN CONSENT. CONTRACTOR SHALL NOT REPRODUCE ANY PORTION OF A CONTRACT DRAWING FOR USE IN ANY PORTION OF A SUBMITTAL.

7. THE GENERAL CONTRACTOR SHALL INVESTIGATE ALL FIELD CONDITIONS RELEVANT TO THE PROJECT INCLUDING, BUT NOT LIMITED TO, DIMENSIONS, ELEVATIONS, GENERAL CONDITIONS AND OTHER SIMULTANEOUS EXISTING CONDITIONS AND SHALL PROMPTLY NOTIFY THE ARCHITECT OF ANY WHICH DO NOT AGREE WITH THOSE IN THESE DRAWINGS.

11. THE GENERAL CONTRACTOR IS RESPONSIBLE FOR SUPPLYING AND INSTALLING ALL COMPONENTS AND ACCESSORIES, EQUIPMENT, MATERIALS, HARDWARE AND OTHER NECESSARY ITEMS, UNLESS NOTED OTHERWISE, FOR A COMPLETE AND FINISHED JOB CONSISTENT WITH THE DESIGN INTENT PRESENTED IN THESE DRAWINGS. COORDINATE THE LOCATION AND INSTALLATION OF ALL MECHANICAL AND ELECTRICAL DEVICES, REGISTERS, FIXTURES, ETC. PRIOR TO INSTALLATION OF FINISH MATERIALS.

12. REFER TO PROJECT MANUAL AND MEP DRAWINGS FOR ADDITIONAL REQUIREMENTS.

	CONCRETE
	BRICK
	CONCRETE MASONRY UNITS (CMU)
	RIGID INSULATION
	BATT INSULATION
	ACOUSTICAL TILE
	GYPSUM BOARD
	PLASTER ON METAL LATH
	CONTINUOUS WOOD
	SHIM BLOCKING
	PLYWOOD
	FINISHED WOOD
	GLASS
	CERAMIC TILE (C.T.)
	QUARRY TILE (Q.T.)
	EARTH
	SAND
	SEALANT
	ROD STOCK AND SEALANT
	METAL
	ALUMINUM
	NATURAL STONE
	EXIST. PARTITION
	NEW PARTITION
	NEW LIGHT FIXT. RE: ELEC.
	EXIS. LIGHT FIXT. RE: ELEC.
	RELOCATED LIGHT FIXTURES

	DOOR NUMBER
	EXTERIOR WINDOW OR OPENING
	BUILDING SECTION DRAWING NUMBER 4 ON SHEET NUMBER A102
	WALL SECTION DRAWING NUMBER 4 ON SHEET NUMBER A102
	DETAIL REFERENCE DRAWING NUMBER 8 ON SHEET NUMBER A10
	DRAWING NUMBER 1 DENOTES DRAWING NUMBER 1 HEAD DENOTES TITLE 1-10 DENOTES SCALE OF DRAWING REF. A43.0 DENOTES REFERENCE TO DRAWING 4 ON SHEET 3.01
	ROOM NUMBER
	INTERIOR ELEVATION INDICATION
	INTERIOR WINDOW OR OPENING
	DIMENSION TO FINISH FACE, UNO.
	DIMENSION TO CENTERLINE
	DIMENSION TO A GIVEN REFERENCE POINT
	LEVEL
	EXIST. GRADE
	FINISHED GRADE
	PARTITION TYPE A REF. FLOOR PLANS PARTITION TYPES
	TOILET ACCESSORY
	EXTERIOR BUILDING ELEVATION
	GLASS TYPES
	DEMOLITION KEY NOTE
	NEW CONSTRUCTION KEY NOTE
	HANDICAP SYMBOL

A3 GENERAL NOTES

COVER	
A001	INDEX, SYMBOLS AND ABBREVIATIONS & LOCATION PLAN
A002	LIFE SAFETY PLAN AND CODE SUMMARY
CIVIL	
C10	CIVIL SITE DEMOLITION PLAN
C10	CIVIL SITE LAYOUT PLAN
C30	CIVIL SITE GRADING AND UTILITY PLAN
C31	OFF-SITE UTILITY CONNECTION
C32	OFF-SITE UTILITY CONNECTION
C33	OFF-SITE UTILITY CONNECTION
C34	OFF-SITE UTILITY CONNECTION
C35	OFF-SITE UTILITY CONNECTION
C36	OFF-SITE UTILITY CONNECTION
C40	CIVIL SITE GENERAL NOTES
C41	CIVIL SITE DETAILS

STRUCTURAL

SD1	PARTIAL PLANS AND DETAILS	1
SD000	GENERAL NOTES	
SD1.01	GROUND LEVEL PLAN	
SD1.02	ROOF LEVEL FRAMING PLAN	
SD2.01	DETAILS	

ARCHITECTURAL

A2.00	FLOOR PLAN- DEMOLITION	
A2.01	FLOOR PLAN- DEMOLITION	
A2.03	RCP- DEMOLITION	
A2.04	RCP- DEMOLITION	
A2.04	ROOF PLAN- DEMOLITION	
A2.04	ROOF PLAN- DEMOLITION	
A1.01	SITE PLAN	
A1.10	SITE DETAILS	
A1.11	SITE DETAILS	⚠
A2.00	FLOOR PLAN- RENOVATION	
A2.01	FLOOR PLAN- RENOVATION	
A2.02	EQUIPMENT 4 FURNITURE PLAN	
A2.03	EQUIPMENT 4 FURNITURE PLAN	⚠
A2.10	RCP- RENOVATION	
A2.11	RCP- RENOVATION	
A2.13	SECURITY PLAN	
A2.20	ENLARGED PLANS	
A2.30	ROOF PLAN- RENOVATION	
A2.31	ROOF PLAN- RENOVATION	
A3.01	EXTERIOR ELEVATIONS	
A3.02	EXTERIOR ELEVATIONS	
A3.03	EXTERIOR ELEVATIONS	
A3.10	EXTERIOR WALL SECTIONS/DETAILS	⚠
A5.01	DOOR SCHEDULES/TYPES/HARDWARE	
A5.02	ROOM FINISH SCHEDULES/SELECTIONS	
A5.30	PARTITION TYPES AND FRAMING DETAILS	
A7.01	INTERIOR ELEVATIONS	
A7.02	INTERIOR ELEVATIONS	
A7.10	INTERIOR DETAILS	
A7.20	INTERIOR DETAILS	
A7.30	MILLWORK DETAILS	

MECHANICAL

M1.00 INFORMATION SHEET AND SCHEDULES-MECHANICAL
M2.01 SCHEDULES-MECHANICAL
M1.00 HVAC EMERGENCY POWER ZONE PLAN-MECHANICAL
MD1.01 DEMOLITION PLAN-MECHANICAL
MD2.01 DEMOLITION ROOF PLAN-MECHANICAL
M1.01 RENOVATION PLAN-MECHANICAL
M2.01 RENOVATION ROOF PLAN-MECHANICAL
M3.00 CONTROLS- MECHANICAL
M3.01 INFORMATION SHEET MECHANICAL 
M4.00 DETAILS- MECHANICAL

ELECTRICAL

E0.00 INFORMATION SHEET- ELECTRICAL
ED0.01 ONE LINE DEMOLITION-ELECTRICAL
E0.01 ONE LINE RENOVATION-ELECTRICAL
E0.02 LOAD ANALYSIS AND LIGHTING SCHEDULE-ELECTRICAL
E0.03 PANEL SCHEDULES- ELECTRICAL
E0.04 PANEL SCHEDULES- ELECTRICAL
E0.05 PANEL SCHEDULES- ELECTRICAL
ED1.00 LIGHTING DEMOLITION PLAN- ELECTRICAL
E1.00 LIGHTING RENOVATION PLAN- ELECTRICAL
E1.01 LIGHTING RENOVATION PLAN- ELECTRICAL
ED2.00 POWER DEMOLITION PLAN- ELECTRICAL
E2.00 POWER RENOVATION PLAN- ELECTRICAL
E2.01 POWER RENOVATION PLAN- ELECTRICAL
ED3.00 EQUIPMENT POWER DEMOLITION PLAN- ELECTRICAL
E3.00 EQUIPMENT POWER RENOVATION PLAN- ELECTRICAL
E3.01 EQUIPMENT POWER RENOVATION PLAN- ELECTRICAL
E4.00 FIRE ALARM RENOVATION PLAN-ELECTRICAL
E5.00 SECURITY RENOVATION PLAN - ELECTRICAL
E6.00 LIGHTNING PROTECTION PLAN - ELECTRICAL
E7.00 LIGHTING CONTROL DETAIL - ELECTRICAL
E7.01 DETAILS - ELECTRICAL
E7.02 DETAILS - ELECTRICAL
E7.03 DETAILS - ELECTRICAL

PLUMBING

P000 INFORMATION SHEET AND SCHEDULES- PLUMBING
FD101 UNDERFLOOR DEMOLITION PLAN- PLUMBING
FD201 DEMOLITION PLAN- PLUMBING
F100 SITE AND ROOF PLAN- PLUMBING
F101 UNDERFLOOR RENOVATION PLAN- PLUMBING
F201 RENOVATION PLAN- PLUMBING
F300 DETAILS PLUMBING

A6 LOCATION PLAN

A4 SCHED OF OFOI SCOPE
NO SCALE

A. FIBER OPTICS CABLEING. NEW FIBER OPTICS CABLEING FOR BLDGS. E WILL ORIGINATE AT BLDG. D. INSTALLATION WILL BE OFOI INCLUDING TRENCHING & CONDUIT.


B. IT/DATA CABLEING. GC TO PROVIDE IT/DATA CABLEING. INFRASTRUCTURE INCLUDING CONDUIT, PULL STRINGS & JUNCTION BOXES. OOFI. GC TO PROVIDE ALL PULL STATIONS & CABLE TRAYS FOR CABLE SUPPORT ARE NOT REQUIRED, CAT6A WILL BE THE INSTALLED CABLEING & WILL BE OFOI.


C. SECURITY. GC TO PROVIDE & INSTALL A COMPLETE SECURITY SYSTEM AS SCHEDULED & SPECIFIED. THE SYSTEM INCLUDES: ACCESS CONTROL, SECURITY EQUIPMENT, PERIMETER DETECTION, CABLEING FOR CARD READERS, PERIMETER DETECTION, FULL STATIONS, DOOR CONTACTS, AND ALL SECURITY EQUIPMENT INCLUDING BUT NOT LIMITED TO ACCESS CONTROL, PANELS, CAMERAS, CARD READERS, MANAGERIAL DEVICES, DETECTORS, DETECTORS, AND INTERCOM / AIPHONES. INFRASTRUCTURE INCLUDING CONDUIT, PULL STRINGS & JUNCTION BOXES. RE. A213 FOR SECURITY. GC TO PROVIDE THE LOCATIONS & QUANTITIES OF THE SECURITY DEVICES.

NETWORK DATA DROP CABLEING (CAT6A) THAT SERVES THE ACCESS CONTROL PANELS, CAMERAS & AIPHONES WILL BE OFOI. GC TO PROVIDE FINAL CONNECTIONS TO THESE DEVICES.

D. AV EQUIPMENT & CABLEING. GC TO PROVIDE AV INFRASTRUCTURE FOR EQUIPMENT & CABLEING. INFRASTRUCTURE INCLUDING CONDUIT, PULL STRINGS & JUNCTION BOXES. EQUIPMENT INCLUDING, BUT IS NOT LIMITED TO WALL MOUNTED MONITORS & BRACKETS, RE: FLOOR PLANS FOR THE LOCATIONS OF AV EQUIPMENT. EQUIPMENT AND AV CABLEING WILL BE OFOI, UNO. RELOCATED MONITOR & NEW WALL BRACKET IN CONFERENCE RTR ERE12309 IS GC.

E. FIRE ALARM SYSTEM. CPCI FOR A COMPLETE SYSTEM AS SCHEDULED & SPECIFIED.

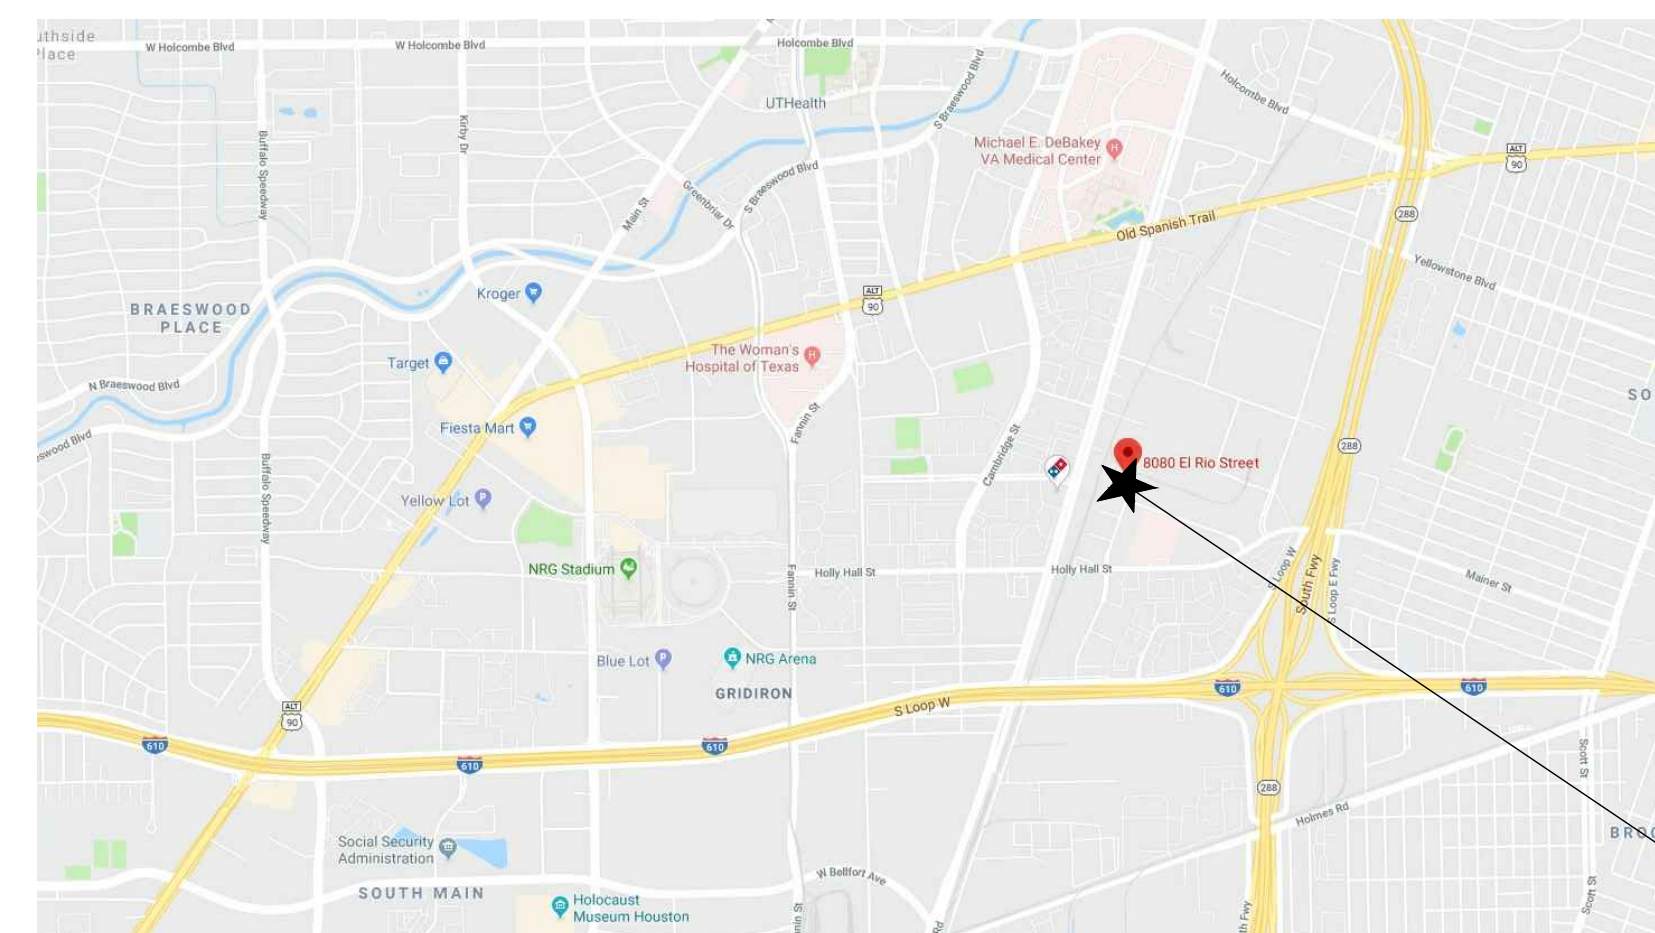


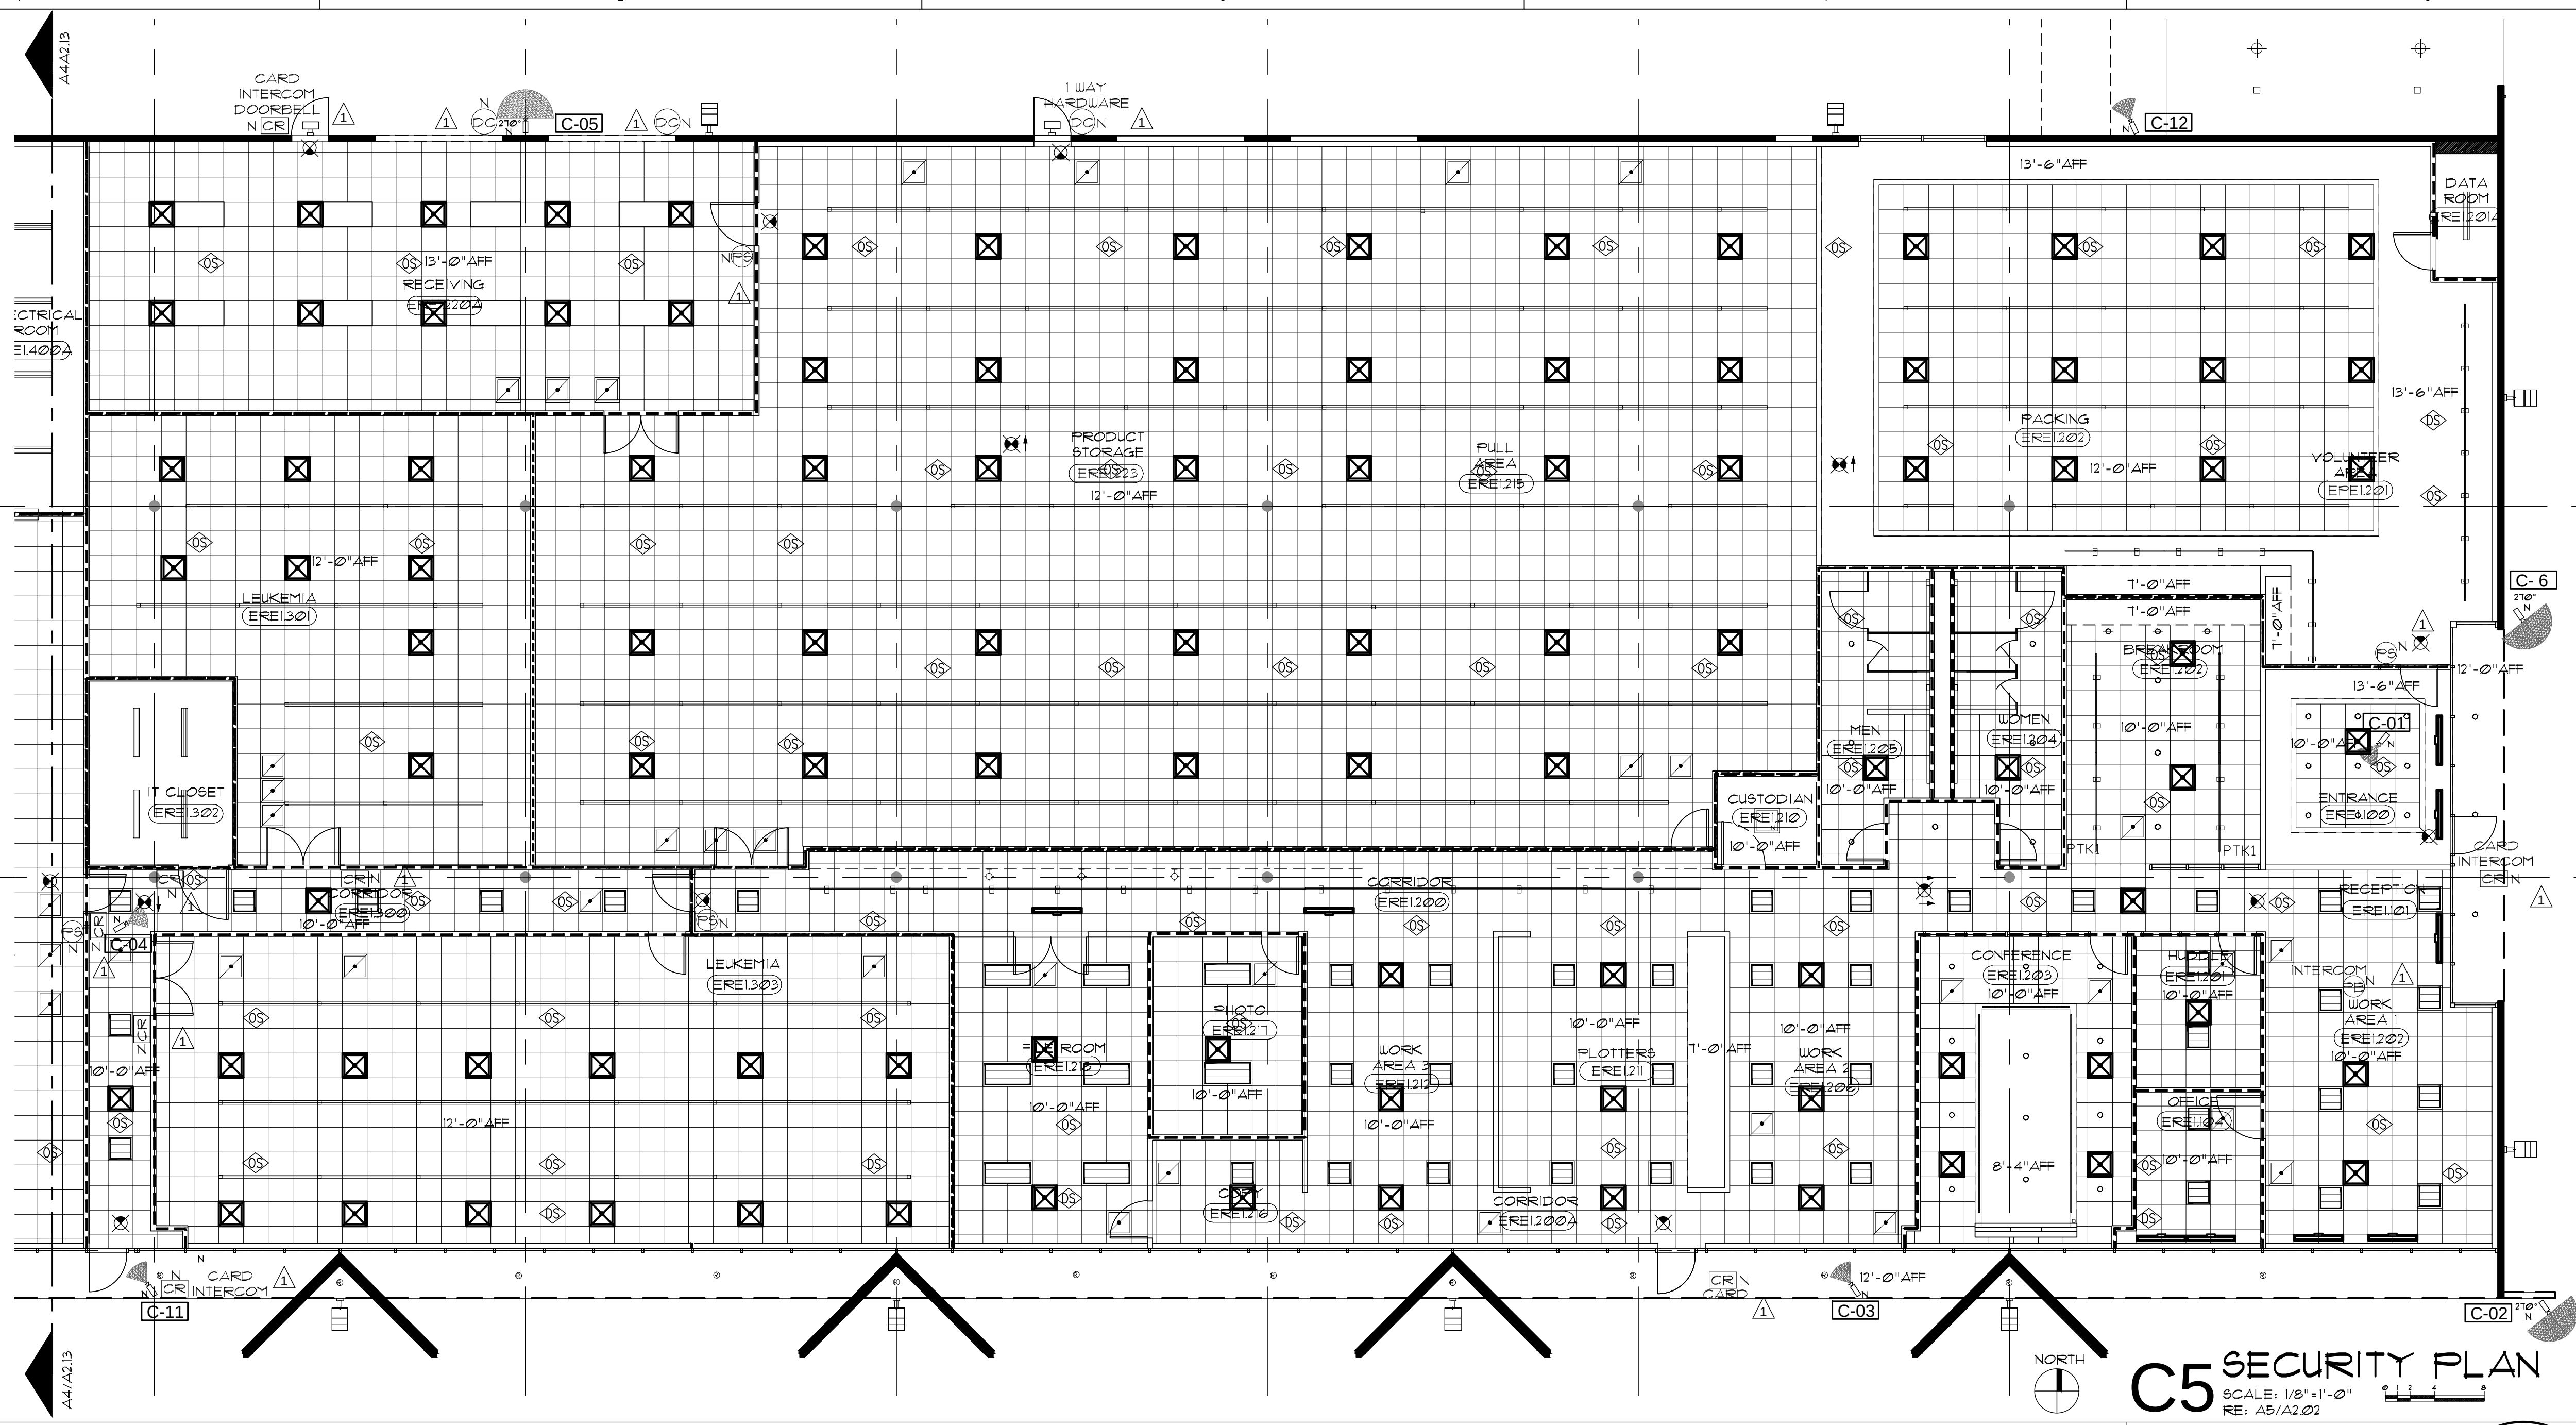

C5 SECURITY PLAN
SCALE: 1/8"=1'-0"
RE: A5/A2.02

- GENERAL NOTES**
- A. THE G.C. WILL PROVIDE & INSTALL ALL SECURITY DEVICES & SECURITY CABLING. DEVICES INCLUDE CAMERAS, FULL STATIONS, CARD READERS, DURESS/PANIC BUTTONS/DOOR CONTACTS/INTERCOM & LAP.
 - B. GENERAL CONTRACTOR TO COORDINATE ALL SECURITY WORK.
 - C. ELECTRICAL CONTRACTOR TO PROVIDE ALL PATHWAYS AND INFRASTRUCTURE TO SUPPORT SECURITY DEVICES.
 - D. ALL CABLING AND PATHWAY COMPONENTS TO BE CONCEALED WITHIN PARTITIONS, ABOVE CEILING AND FURRED/DUNS. PATCH / REPAIR PARTITIONS AS REQUIRED FOLLOWING CABLING INSTALLATION.
 - E. ALL HARDWARE AND SECURITY DEVICE DEMOLITION / INSTALLATION TO BE PERFORMED BY A VETTED SECURITY CONTRACTOR ACCEPTABLE TO UTPD TECH SERVICES. THE FOLLOWING VENDORS / INSTALLERS ARE ACCEPTABLE TO UTPD:
 - 1. FIRETRON PROTECTION SYSTEMS, JON CHESNUTT, 713/343-1600, JCHESNUTT@FIRETRON.NET
 - 2. NEXTGEN SECURITY, MARCO SEGURA, 832-410-1374, MARCO@NEXTGENSECURED.COM
 - 3. PREFERRED TECHNOLOGIES, LLC, KADE KAAZ, 281-881-3183, KADEKAAZ@PREF-TECH.COM
 - F. G.C. TO CONFIRM WITH OWNER & UTPD MOUNTING HEIGHTS & LOCATIONS OF ALL CAMERAS PRIOR TO ROUGH IN INSTALLATION.
 - G. ACCESS CONTROL CABLING TO BE PROVIDED & INSTALLED BY G.C. THIS INCLUDES CABLING SERVING THE CR, PB, PS, & DC.
 - RE: SECTION 28.00.00 PART 2.02 BB WIRE & CABLE, GENERAL.
 - H. NETWORK DATA DROP CABLING SERVING THE CAMERAS, IPHONES, & ACCESS CONTROL PANELS WILL BE PROVIDED & INSTALLED BY THE OWNER'S CABLING CONTRACTOR. G.C. TO PROVIDE FINAL CONNECTIONS TO EACH OF THESE DEVICES.
- ELECTRICAL**
- A. ELECTRICAL CONTRACTOR SHALL PROVIDE ALL MATERIALS & LABOR TO PROVIDE A COMPLETE SECURITY CABLING PATHWAY CONCEALED WITHIN PARTITIONS & CEILINGS. ELECTRICAL POWER DISTRIBUTION & GROUND SYSTEM AS SET FORTH IN THE DOCUMENTS. ALL NEW SECURITY DEVICES WILL REQUIRE NEW CABLES & ROUGH IN PATHWAYS.
 - B. ALL COMPONENT & DEVICES SHOWN ON THESE DRAWINGS ARE FOR APPROXIMATE LOCATION & POSITIONING ONLY. VERIFY WITH OWNER EXACT LOCATIONS PRIOR TO INSTALLATION.
 - C. ELECTRICAL CONTRACTOR SHALL INSTALL POWER AS REQUIRED BY THE SECURITY SYSTEM & COORDINATED BY THE SECURITY CONTRACTOR.
 - D. ELECTRICAL CONTRACTOR SHALL PROVIDE & INSTALL ALL CONDUITS, FULL STRINGS, CORES & JUNCTION BOXES AS REQUIRED FOR SECURITY DEVICE INSTALLATION. ALL PATHWAYS PENETRATING EXTERIOR WALLS WILL BE MADE WATERTIGHT.
 - E. ALL SECURITY PATHWAY CONDUITS SHALL BE PROPERLY FIRESTOPPED & LABELED.
 - F. PROVIDE CONDUIT FOR SECURITY DEVICES THAT ARE IN OPEN CEILING SPACES TO ACCESSIBLE CEILING.

GENERAL C6 SECURITY NOTES
RE: PLANS/A2/A13

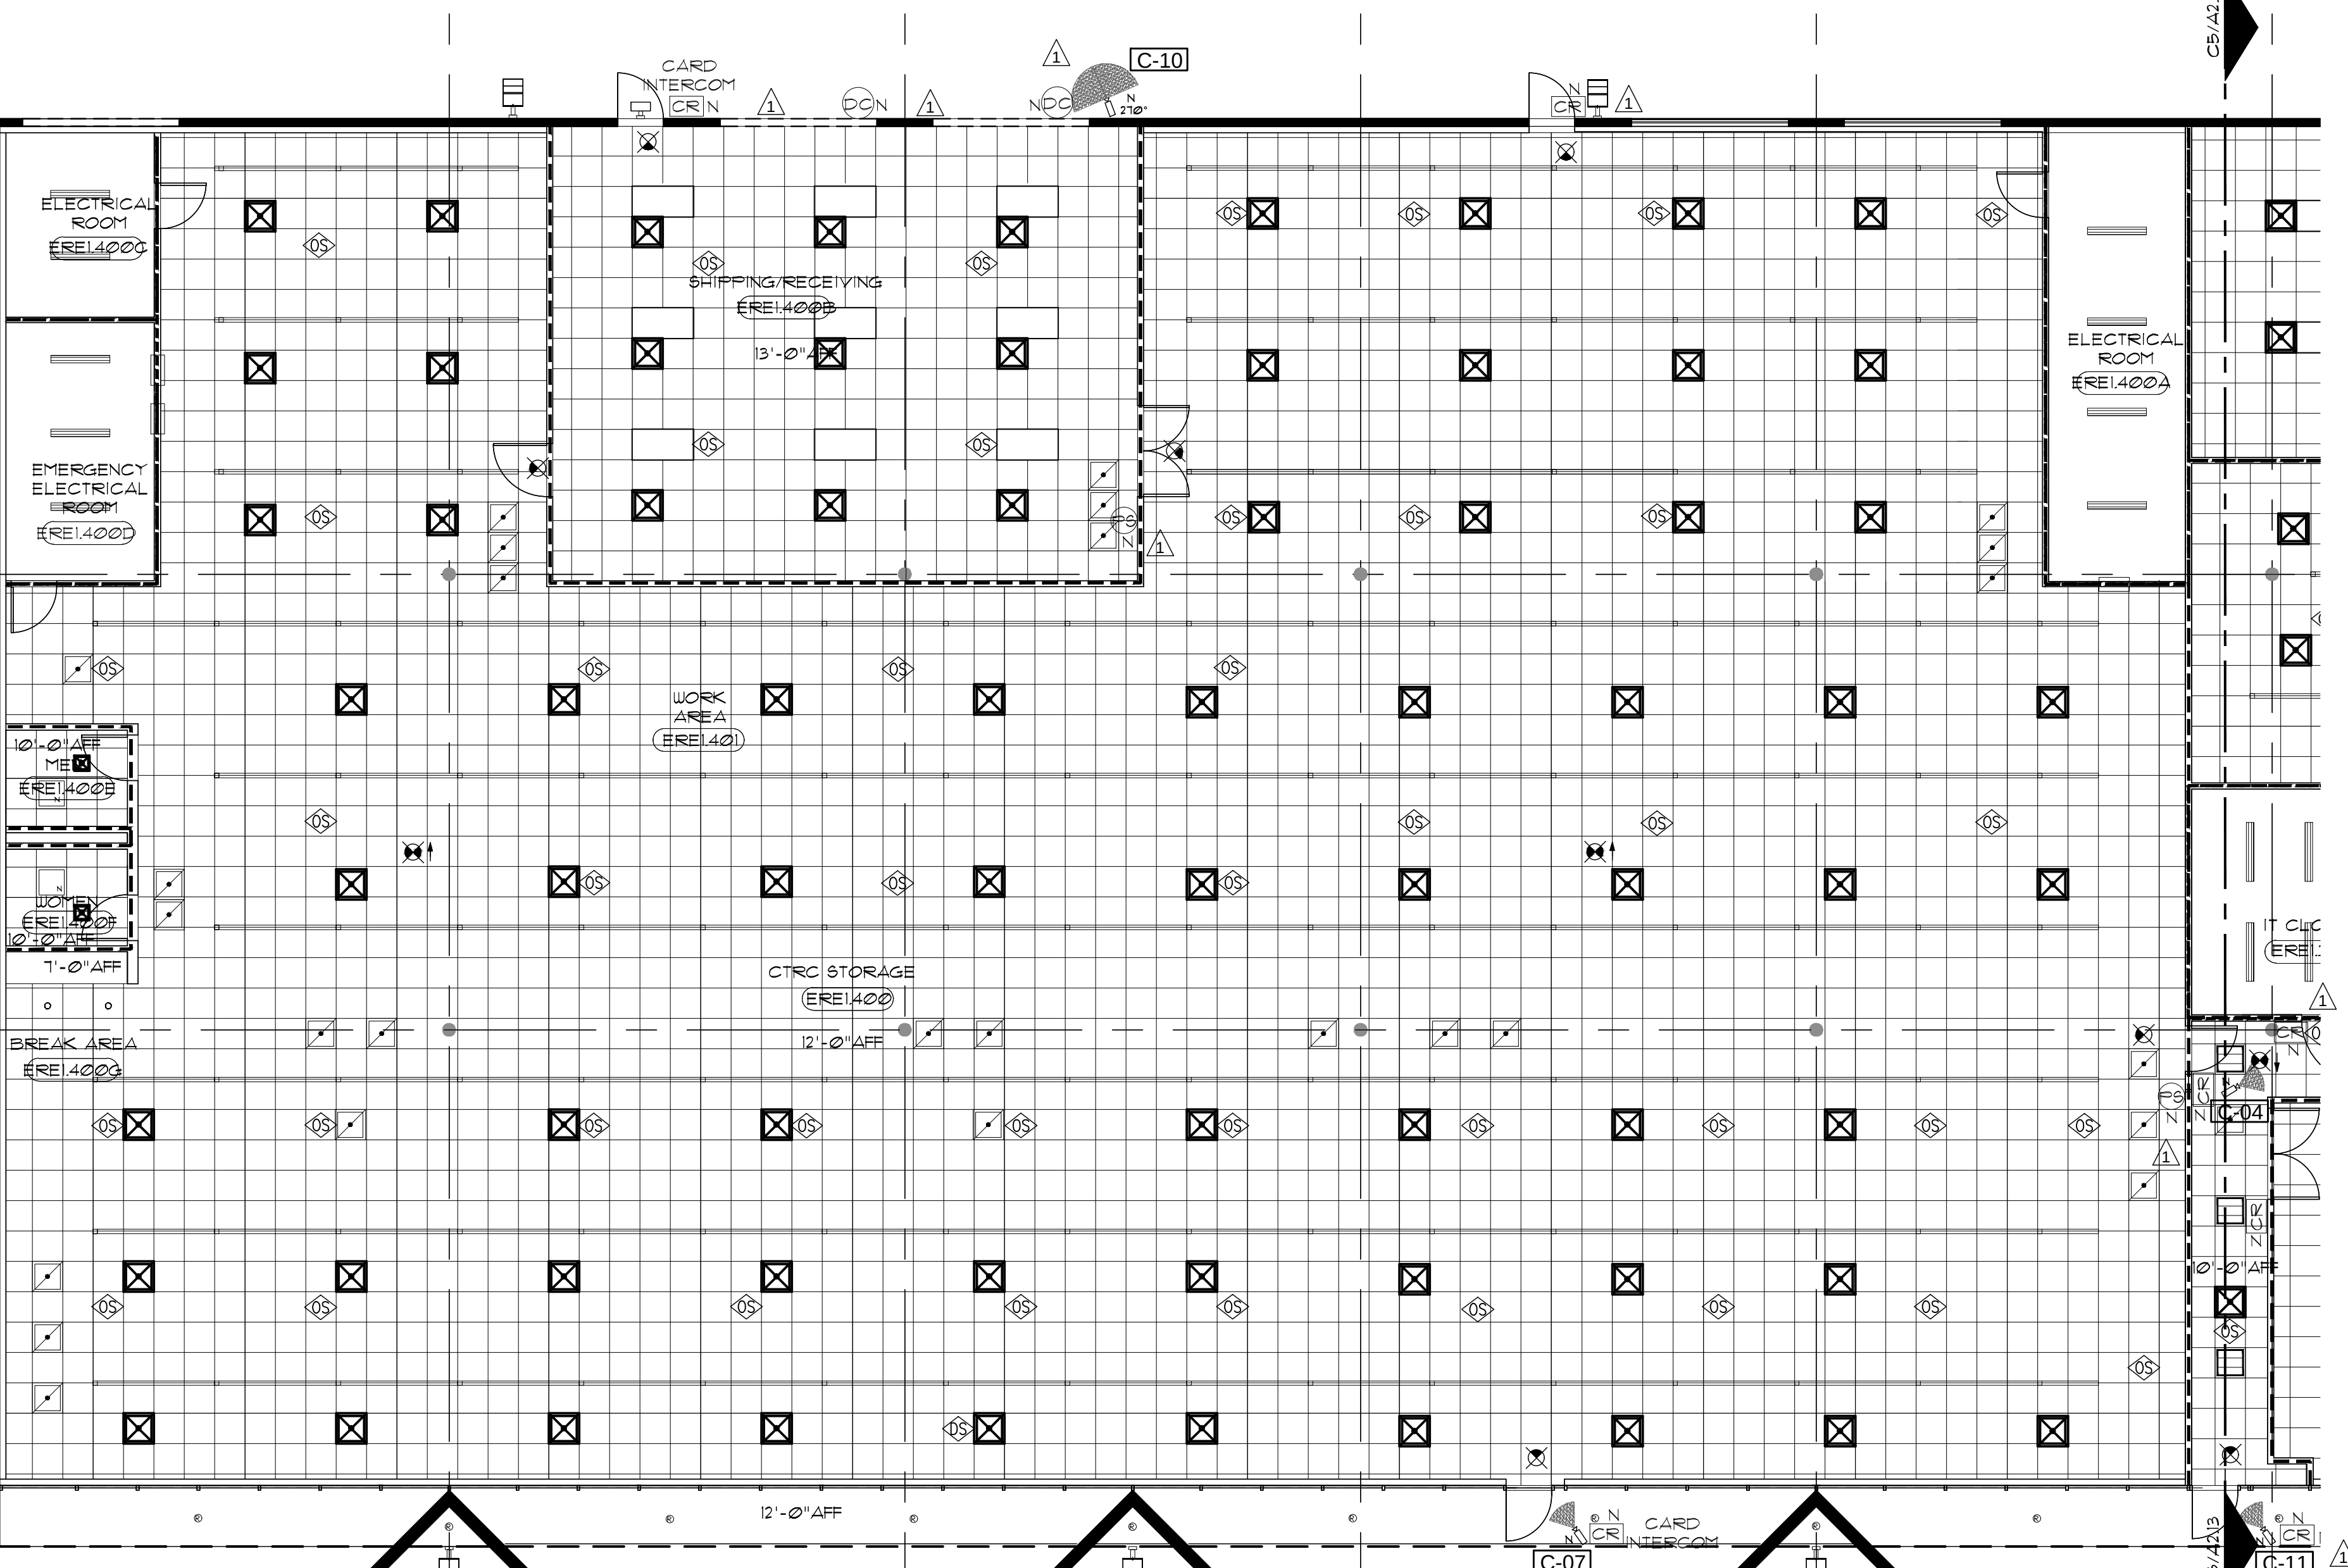

A4 SECURITY PLAN
SCALE: 1/8"=1'-0"
RE: A5/A2.03

ROOM LOCATION	CAMERA NUMBER	MOUNT TYPE	MOUNT HEIGHT	REMARKS
ENTRY ERE1100	C-01	CLG. MTD	10'-0" AFF	BASE COVERAGE FIXED VIEW FINISH CLG. IS ACT. RE: SECTION 28.10.00. PART 2.02 C VARIOUS OUTDOOR CAMERA.
SOUTH EXTERIOR	C-02	WALL MTD	12'-0" AFF	210 DEGREE COVERAGE PANORAMIC MOUNTING BRACKET RE: SECTION 28.10.00. 210 DEGREE COVERAGE PROVIDE SURFACE MOUNT BRACKET PLASTER SOFFIT.
SOUTH EXTERIOR	C-03	SOFFIT MTD	12'-0" AFF	210 DEGREE COVERAGE PROVIDE SURFACE MOUNT BRACKET PLASTER SOFFIT.
CORRIDOR ERE1300	C-04	CLG. MTD	10'-0" AFF	BASE COVERAGE FIXED VIEW FINISH CLG. IS ACT. RE: SECTION 28.10.00. PART 2.02 C VARIOUS OUTDOOR CAMERA.
NORTH EXTERIOR	C-05	WALL MTD	12'-0" AFF	210 DEGREE COVERAGE PANORAMIC MOUNTING BRACKET RE: SECTION 28.10.00. PART 2.02 C VARIOUS OUTDOOR CAMERA.
NORTH EXTERIOR	C-06	WALL MTD	12'-0" AFF	210 DEGREE COVERAGE PANORAMIC MOUNTING BRACKET RE: SECTION 28.10.00. PART 2.02 C VARIOUS OUTDOOR CAMERA.
SOUTH EXTERIOR	C-07	SOFFIT MTD	12'-0" AFF	210 DEGREE COVERAGE PANORAMIC MOUNTING BRACKET RE: SECTION 28.10.00. PART 2.02 C VARIOUS OUTDOOR CAMERA.
SOUTH EXTERIOR	C-08	WALL MTD	12'-0" AFF	210 DEGREE COVERAGE PANORAMIC MOUNTING BRACKET RE: SECTION 28.10.00. PART 2.02 C VARIOUS OUTDOOR CAMERA.
NORTH EXTERIOR	C-09	WALL MTD	12'-0" AFF	210 DEGREE COVERAGE PANORAMIC MOUNTING BRACKET RE: SECTION 28.10.00. PART 2.02 C VARIOUS OUTDOOR CAMERA.
NORTH EXTERIOR	C-10	WALL MTD	12'-0" AFF	210 DEGREE COVERAGE PANORAMIC MOUNTING BRACKET RE: SECTION 28.10.00. PART 2.02 C VARIOUS OUTDOOR CAMERA.
SOUTH EXTERIOR	C-11	SOFFIT MTD	12'-0" AFF	210 DEGREE COVERAGE PANORAMIC MOUNTING BRACKET RE: SECTION 28.10.00. PART 2.02 C VARIOUS OUTDOOR CAMERA.
NORTH EXTERIOR	C-12	WALL MTD	12'-0" AFF	210 DEGREE COVERAGE PANORAMIC MOUNTING BRACKET RE: SECTION 28.10.00. PART 2.02 C VARIOUS OUTDOOR CAMERA.

B6 CAMERA SCHEDULE
RE: PLANS/A2/A13

SECURITY DEVICES	MODEL / REMARKS
PS	POLICE FULL STATION
PB	PANIC BUTTON
CR	CARD READER
IP INTERCOM	NETWORK INTERCOMS
DC	ALARMED DOOR CONTACTS
REMARKS: 1. TYP. & FULL STATION: PROVIDE BACK BOX & STUBUP CONCEALED IN PARTITION	

A6 DEVICES
RE: PLANS/A2/A13

THE UNIVERSITY OF TEXAS
MD ANDERSON
CANCER CENTER

COURTNEY
HARPER
A PARTNERS ARCHITECTS

3801 KIRBY, SUITE 244
HOUSTON, TEXAS 77098
713.521.2739 T
713.521.4558 F

Revision/Issues
10.29.2019 Issued for CSP & TDLR Review
02.18.2020 Addendum #02
02.24.2020 Addendum #03

University of Texas MD Anderson Cancer Center
8080 El Rio St. Houston, TX 77054
MDACC Project No. 17-0457
MDACC El Rio INFRASTRUCTURE UPGRADES

REGISTERED ARCHITECT
COURTNEY HARPER
STATE OF TEXAS
02.24.2020

REVISION/ISSUE 01.31.2020
MDACC NO. 17-0457
CHAP. NO. 18-024
LOCATION El Rio
DRAWN BY SWC
CHECKED BY CHC
SHEET TITLE: Security Plan

SHEET:
A2.13
OF